


OPERATING DESCRIPTION:
 THIS SYSTEM WILL PUMPED BOTH CHILD AND HOT WATER
 BYE SAME CIRCULATING PUMP UNIT
 FOR SUMER 2 PUMP WILL BE OPERATED 30 min OR 60 min
 AND COULD BE CHANGE OVER WITH STAND BY UNIT
 FOR WINTER ONLY ONE UNIT WILL OPERATED 30 min

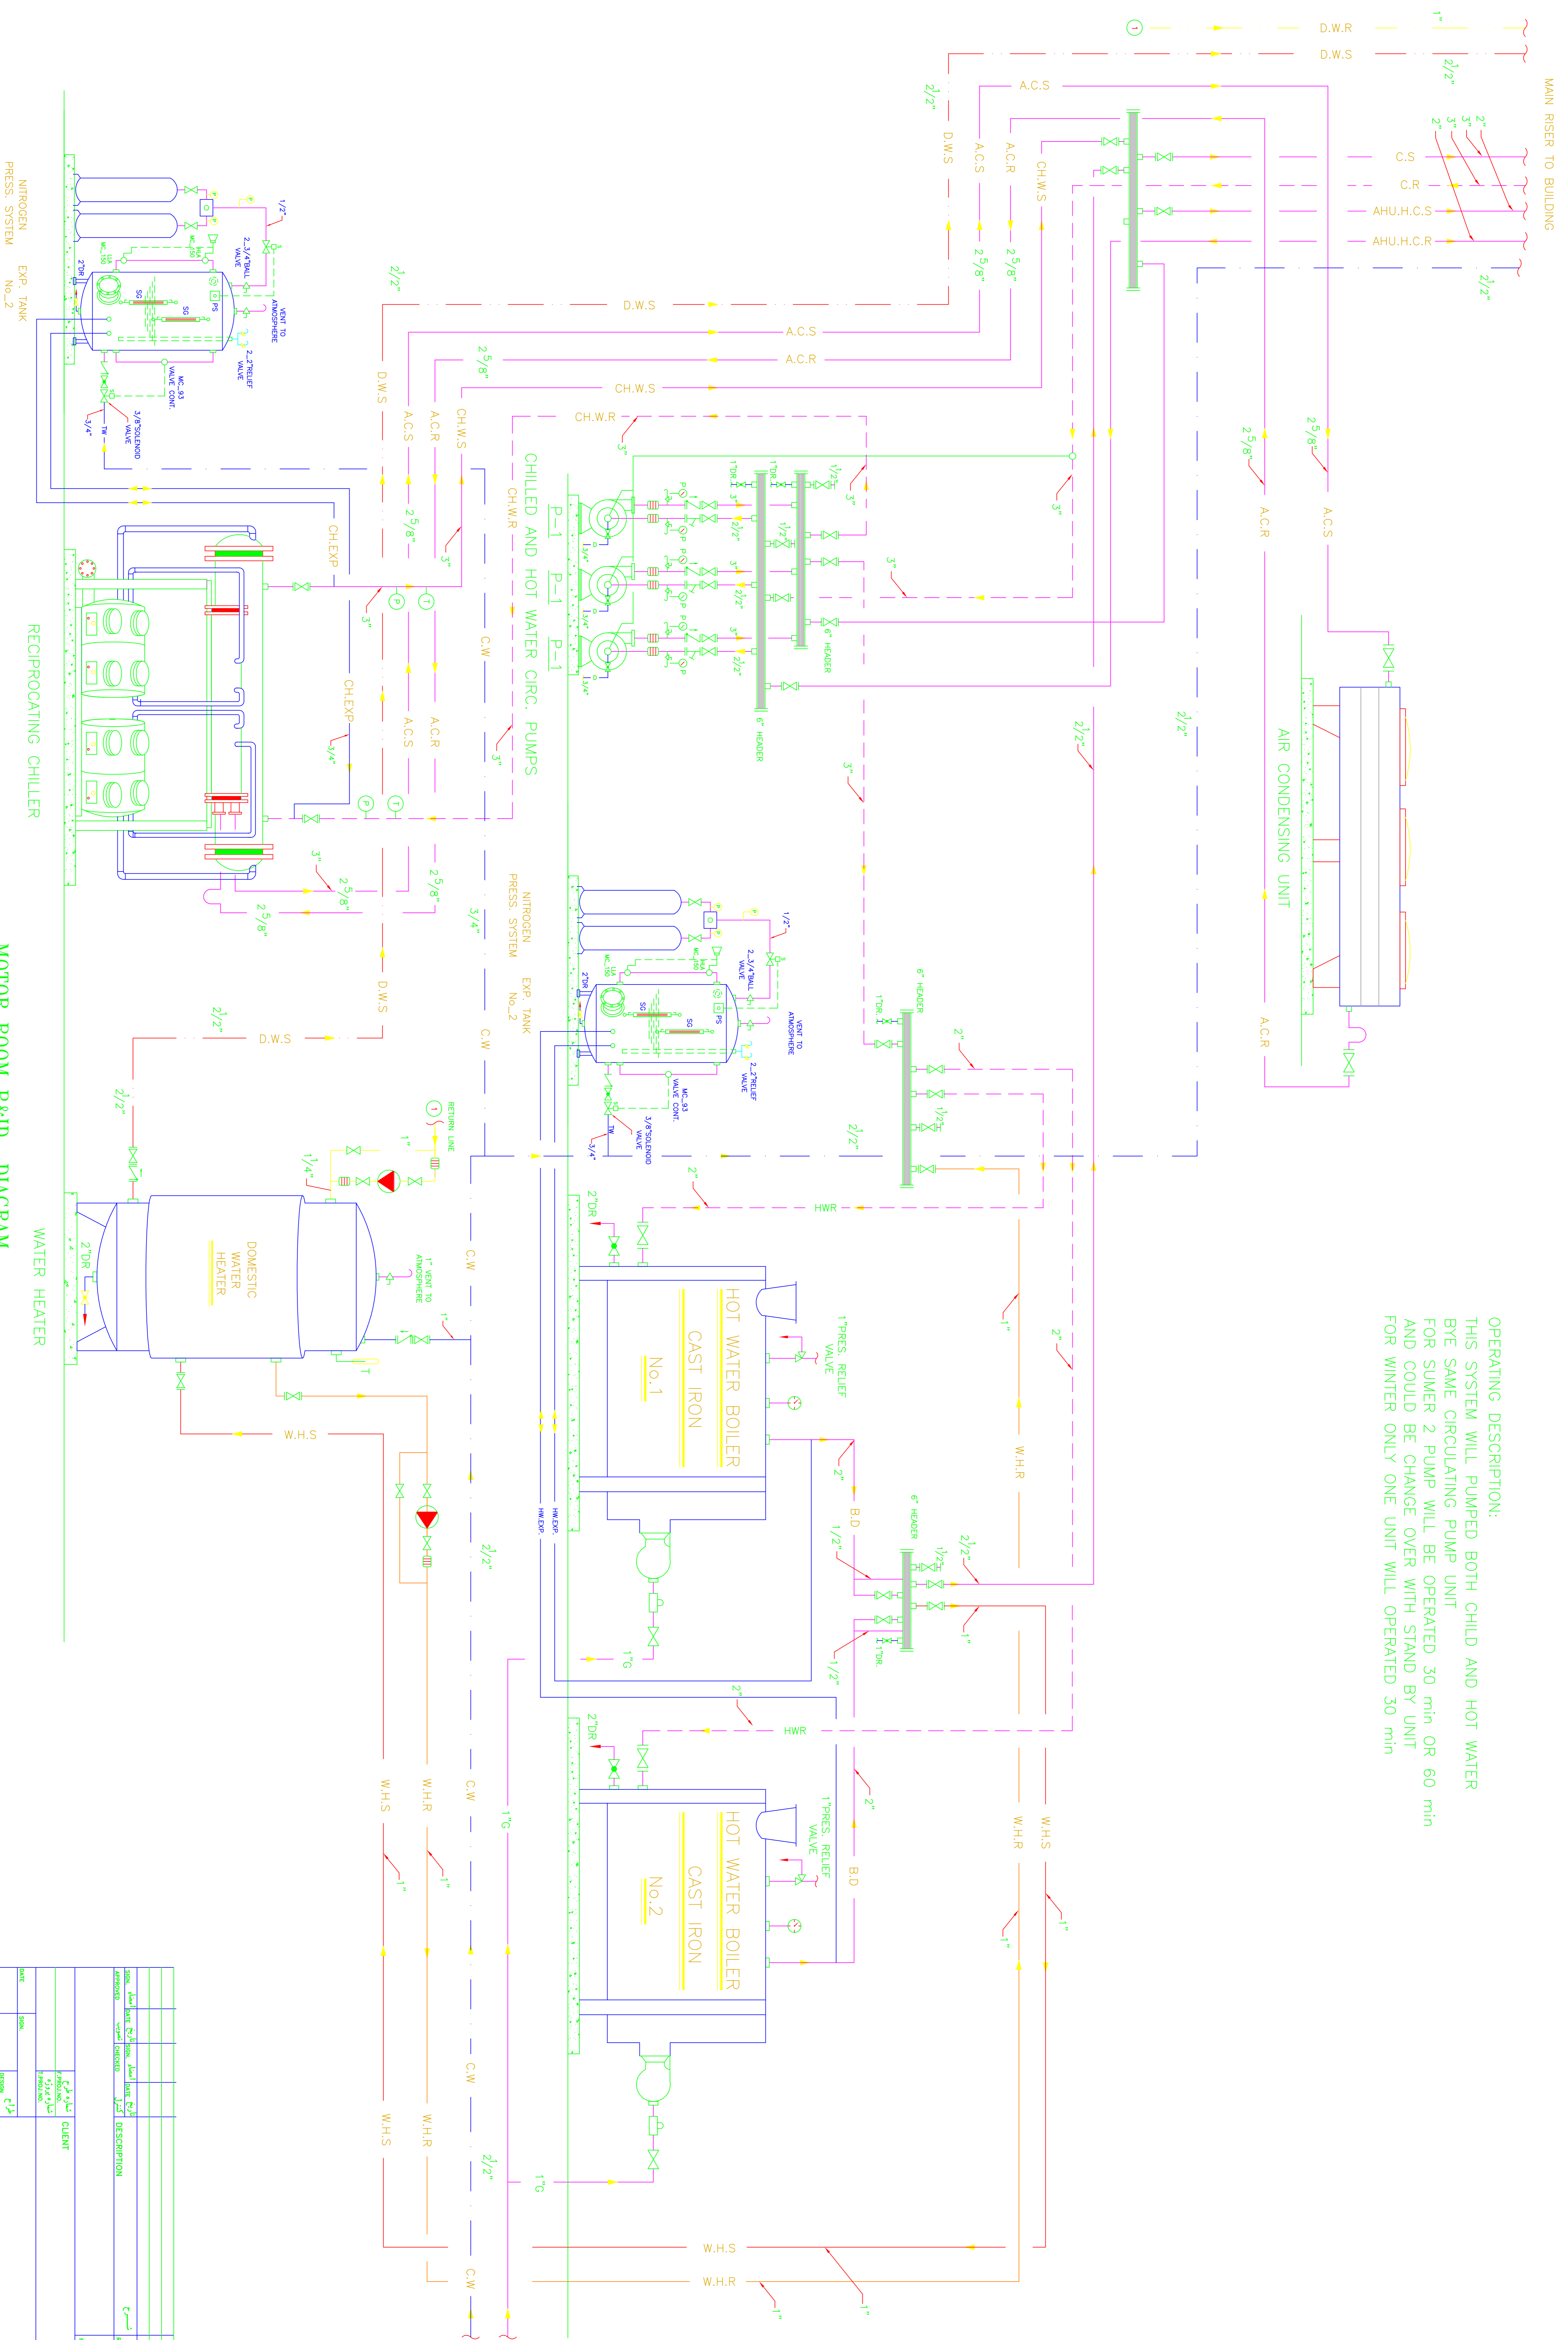

MOTOR ROOM P&ID DIAGRAM
 SCALE: N1:5

DATE	REVISION	DESCRIPTION

CLIENT	CLIENT NAME

DESCRIPTION	SCALE

DRAWING NO.	UNIT
M-13	